

INDEX OF DRAWINGS

GENERAL	CUR	CURRENT REVISION
T1.0	COVER SHEET	0
GN1.0	CODES AND LOCAL NOTES	0
GN1.1	DUNKIN SPECIFICATIONS	0
GN1.2	DUNKIN SPECIFICATIONS	0
GN1.3	DUNKIN SPECIFICATIONS	0
GN1.4	DUNKIN SPECIFICATIONS	0
GN1.5	DUNKIN SPECIFICATIONS	0
GN1.6	DUNKIN SPECIFICATIONS	0
GN1.7	DUNKIN SPECIFICATIONS	0
GN1.8	DUNKIN SPECIFICATIONS	0
GN2.0	MASTER FINISH SCHEDULE	0
GN2.1	MASTER FINISH SCHEDULE	0
GN2.2	MASTER FINISH SCHEDULE	0
GN2.3	MASTER FINISH SCHEDULE	0
GN2.4	MASTER FINISH SCHEDULE	0
GN2.5	MASTER FINISH SCHEDULE	0
GN2.6	MASTER FINISH SCHEDULE	0
GN3.0	NATIONAL ACCOUNTS	0
GN4.0	GENERAL NOTES	0
GD1.0	ACCESSIBILITY DETAILS	0
GD1.1	SEISMIC DETAILS	0
GD2.0	WALL TYPES - WOOD	0
LIFE SAFETY PLAN	LIFE SAFETY PLAN	0
LP1.0	LIFE SAFETY PLAN	0
ARCHITECTURAL		
AR1.1	ELEVATION STUDY	0
SP1.0	ARCHITECTURAL SITE PLAN	0
SP2.0	SITE DETAILS	0
A1.0	FLOOR PLAN - NEW WORK - FULL BUILDING	0
A1.1	FLOOR PLAN - DIMENSION PLAN FULL BUILDING	0
A1.2	FLOOR PLAN - SUITE A - DUNKIN	0
A1.2.1	ENLARGED PLANS - DUNKIN	0
A1.3	FLOOR PLAN - SUITE B AND C	0
A2.0	REFLECTED CEILING PLAN - DUNKIN SUITE	0
A2.1	REFLECTED CEILING PLAN - SUITE B & C	0
A2.3	ROOF DETAILS	0
A3.0	FINISH PLAN - DUNKIN	0
A3.1	FINISH PLAN - SUITES B & C	0
A4.1	ROOF DETAILS	0
A5.0	EXTERIOR ELEVATIONS	0
A5.1	EXTERIOR ELEVATIONS	0
A5.2	EXTERIOR ELEVATIONS	0
A6.0	BUILDING SECTIONS	0
A6.1	WALL SECTIONS	0
A6.2	WALL SECTIONS	0
A6.3	WALL SECTIONS	0
A7.0	EXTERIOR DETAILS	0
A7.1	EXTERIOR DETAILS	0
A7.2	EXTERIOR DETAILS	0
A7.3	EXTERIOR DETAILS - EIFS	0
A7.4	EXTERIOR DETAILS - EIFS	0
A8.0	INTERIOR ELEVATIONS-DUNKIN	0
A8.1	INTERIOR ELEVATIONS-DUNKIN	0
A8.2	INTERIOR ELEVATIONS-DUNKIN	0
A8.3	INTERIOR ELEVATIONS-DUNKIN	0
A9.0	DETAILS - INTERIOR	0
A9.1	DETAILS - INTERIOR	0
A10.0	DOOR INFORMATION	0
A10.1	WINDOW INFORMATION	0
A10.2	STOREFRONT SYSTEM INFORMATION	0
K1.1	FLOOR PLAN - NEW EQUIPMENT	0
K2.1	KITCHEN EQUIPMENT SCHEDULE	0
CIVIL		
C0	CIVIL COVER	0
C1	GENERAL CONSTRUCTION NOTES	0
C2	EXISTING CONDITIONS	0
C3	DEMOLITION PLAN	0
C4	LAYOUT PLAN	0
C5	GRADING PLAN	0
C6	DRAINAGE PLAN	0
C7	STORM PILE PROFILES	0
C8	ODOT DETAILS	0
C9	WATER PLAN	0
C10	SANITARY SEWER PLAN	0
C11	DETAILS 1	0
C12	DETAILS 2	0
C13	ESSG PLAN	0
C14	ESSG DETAILS	0
C15	LANDSCAPE PLAN	0
C16	LANDSCAPE DETAILS AND NOTES	0
STRUCTURAL		
S0.1	SPECIFICATIONS AND DESIGN CRITERIA	0
S1.1	STRUCTURAL PLAN	0
S1.2	STRUCTURAL PLAN	0
S1.3	STRUCTURAL PLAN	0
S2.1	STRUCTURAL SECTIONS	0
S2.2	STRUCTURAL SECTIONS	0
S3.1	STRUCTURAL DETAILS	0
PLUMBING		
P0.1	PLUMBING SERVICE PLAN	0
P1.0	PLUMBING NOTES AND SPECIFICATIONS	0
P1.1	PLUMBING SPECIFICATIONS	0
P1.2	PLUMBING WATER GAS, VENT AND SANITARY PLANS	0
P2.0	PLUMBING DETAILS AND RISERS	0
P3.0	PLUMBING DETAILS	0
P3.1	PLUMBING DETAILS	0
P4.0	PLUMBING WATER FILTRATION SYSTEM	0
MECHANICAL		
M0.1	MECHANICAL NOTES AND FLOOR PLAN - SHELL	0
M0.2	MECHANICAL ROOF PLAN & SCHEDULE - SHELL	0
M0.3	MECHANICAL DETAILS - SHELL	0
M1.0	MECHANICAL FLOOR PLAN & NOTES	0
M1.1	MECHANICAL ROOF PLAN	0
M2.0	MECHANICAL SCHEDULES	0
M2.1	MECHANICAL DETAILS	0
M3.0	MECHANICAL HOOD DETAILS	0
M4.0	CAPTIVEAIRE HOOD DATA	0
ELECTRICAL		
E0.1	ELECTRICAL SERVICE PLAN	0
E0.2	ELECTRICAL RISER	0
E0.3	ELECTRICAL PANEL SCHEDULE	0
E1.0	LIGHTING PLAN	0
E2.0	ELECTRICAL POWER PLAN AND ELEVATIONS	0
E2.1	ELECTRICAL ROOF PLAN	0
E2.2	ELECTRIC POWER AND ELEVATIONS	0
E3.0	TECHNOLOGY POS PLAN	0
E3.1	TECHNOLOGY DETAILS	0
E4.0	ELECTRICAL SCHEDULE AND DETAILS	0
E4.1	ELECTRICAL RISER AND DETAILS	0
E5.0	ELECTRICAL AUTOMATIC CONTROL PANEL	0
E6.0	ELECTRICAL SITE PLAN	0


INSPIRE
Brands

BUILDING SHELL AND OMNI STORE

FOR

DUNKIN'

LOWNDES DONUTS

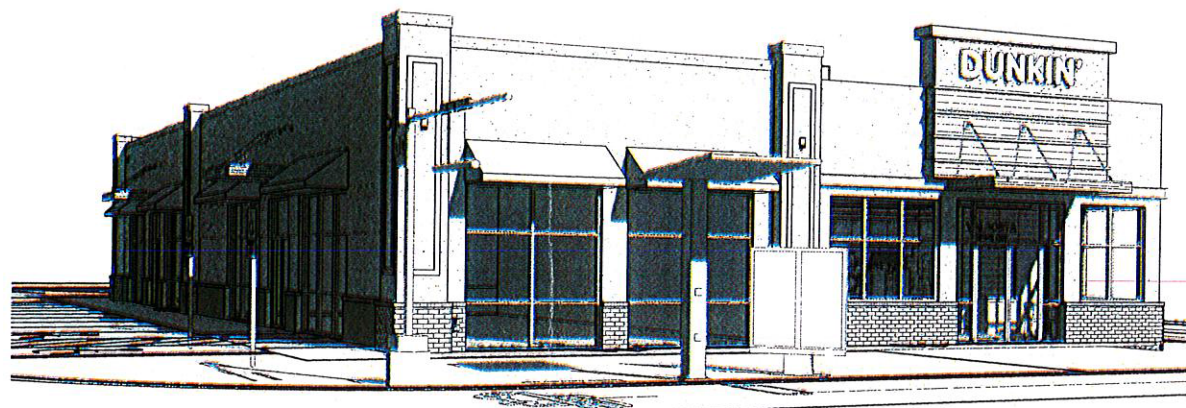


PROJECT NARRATIVE

A NEW THREE TENANT SHELL WITH A DUNKIN AS ONE OF THE TENANTS. SITE WORK, EXTERIOR SHELL WORK, WARM DARK SHELL FOR TWO SUITES AND THE DUNKIN INTERIOR WORK

REVISION HISTORY

REVISION NO.	REVISION DATE	REVISION DESCRIPTION
0	11/08/24	INITIAL ISSUE

VICINITY MAP

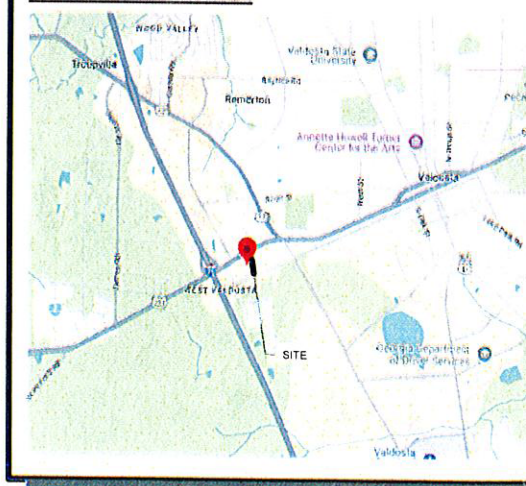

AERIAL VIEW



PC 365477

1805 WEST HILL AVE

VALDOSTA, GEORGIA 31601

PROJECT TEAM


OWNER	LOWNDES DONUTS, LIMITED
FRANCHISEE	LIABILITY COMPANY 319 N. COLLEGE STREET HOMERVILLE, GA, 31634
ARCHITECT	EDWARD L. COPELAND AIA, NCARB COPELAND ARCHITECTURE - GEORGIA OFFICE 2312 PEACHTREE ROAD SUITE B ATLANTA, GEORGIA 30338 PHONE [REDACTED] FAX [REDACTED]
PROJECT MANAGER	ROBERT GREENE COPELAND ARCHITECTURE - FLORIDA OFFICE INVERNESS, FLORIDA 34453 PHONE [REDACTED] FAX [REDACTED]
STRUCTURAL ENGINEER	SAM DEAN BELT ENGINEERING 1503 W. BUSCH BLVD, TAMPA FL 33612
MECHANICAL ENGINEER	ANKIT JAVERI NEARBY ENGINEERS 382 NE 191ST ST, SUITE 45674 MIAMI, FLORIDA 33179
PLUMBING ENGINEER	ANKIT JAVERI NEARBY ENGINEERS 382 NE 191ST ST, SUITE 45674 MIAMI, FLORIDA 33179
ELECTRICAL ENGINEER	ANKIT JAVERI NEARBY ENGINEERS 382 NE 191ST ST, SUITE 45674 MIAMI, FLORIDA 33179

NO.	DATE	DESCRIPTION
0	11/08/24	INITIAL ISSUE

This Drawing and all associated designs are the property of COPELAND ARCHITECTURE and shall be returned upon completion of work. Use or copy is permitted by contract only. Unauthorized use will be prosecuted.



BUILDING SHELL AND OMNI STORE
for
LOWNDES DONUTS
PC 365477
1805 WEST HILL AVE
VALDOSTA, GEORGIA 31601

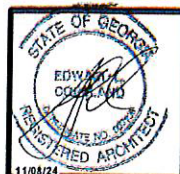

COVER SHEET
COPELAND ARCHITECTURE
2312 PEACHTREE ROAD SUITE B
ATLANTA, GA 30338
PH. [REDACTED] FAX [REDACTED]
WWW.COPELANDARCHITECTURE.COM

DRAWN BY: RMG
CHECKED BY: ELC
DATE: 11/08/24
SCALE: AS NOTED
C.A. COMMISSION NUMBER 2413

SHEET NAME
COVER SHEET

SHEET NUMBER

CVR

0 INITIAL ISSUE 11/08/24

RELEASED FOR CONSTRUCTION

